

ARCHITECT

STRUCTURAL ENGINEER

SANITARY ENGINEER

ELECTRICAL ENGINEER

NOTE:

REVISION		
NO.	DATE	DESCRIPTION
00	3/2/2565	FOR APPROVAL

PROJECT
RS HOUSE ZONE A
STEAM ROOM SYSTEM
(14Kw.)

TITLE
INSTALLING DETAIL
PLAN AND SECTION

APPROVAL BY

DRAWN BY

นายสมศักดิ์ แสงมณี


SCALE
1:50

DATE
25/03/2565


DWG. NO.

TOTAL


S-02

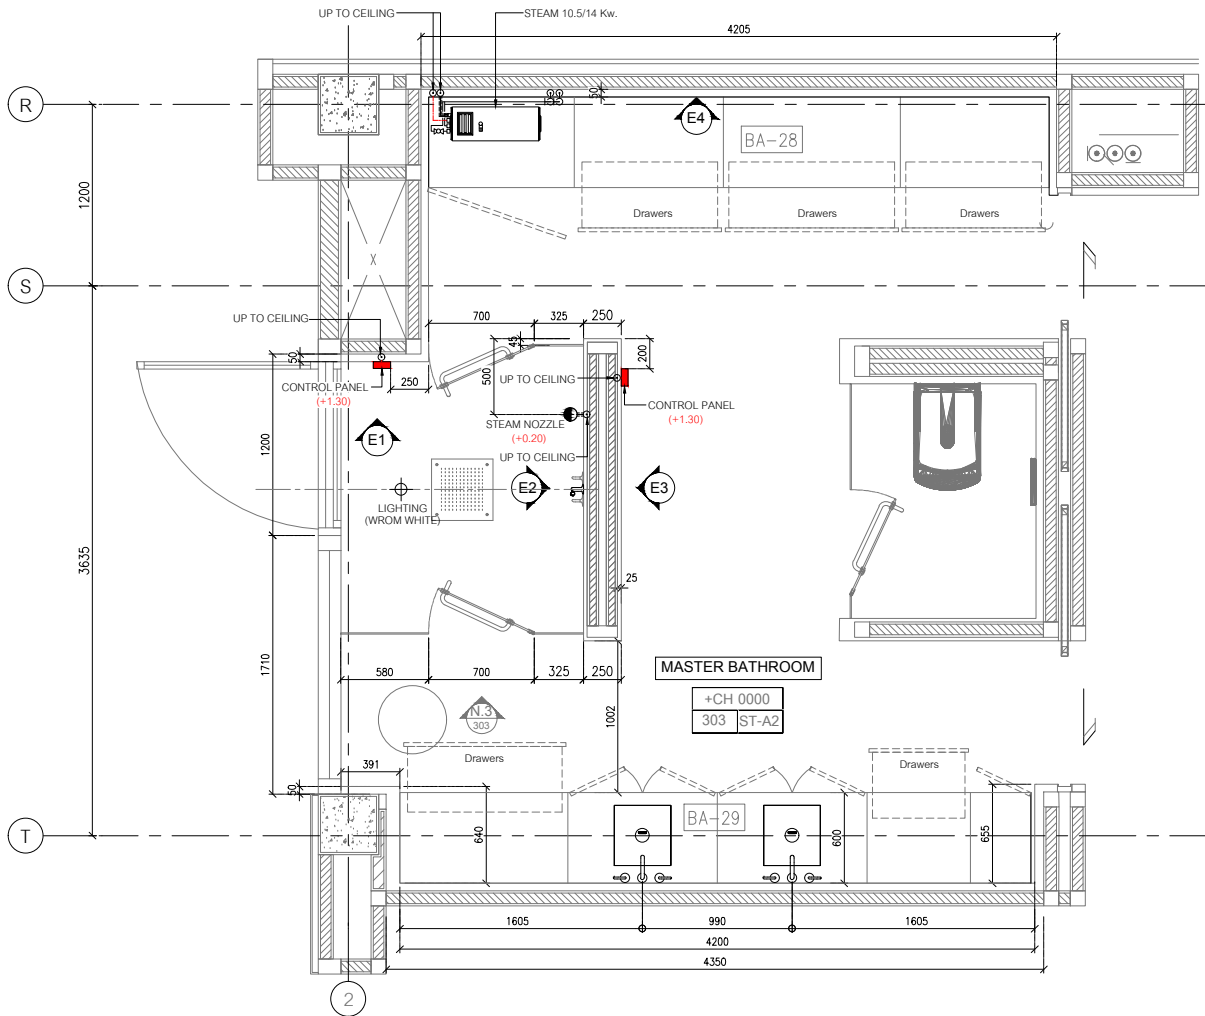


MASTER BATHROOM FLOOR PLAN
SCALE 1:50

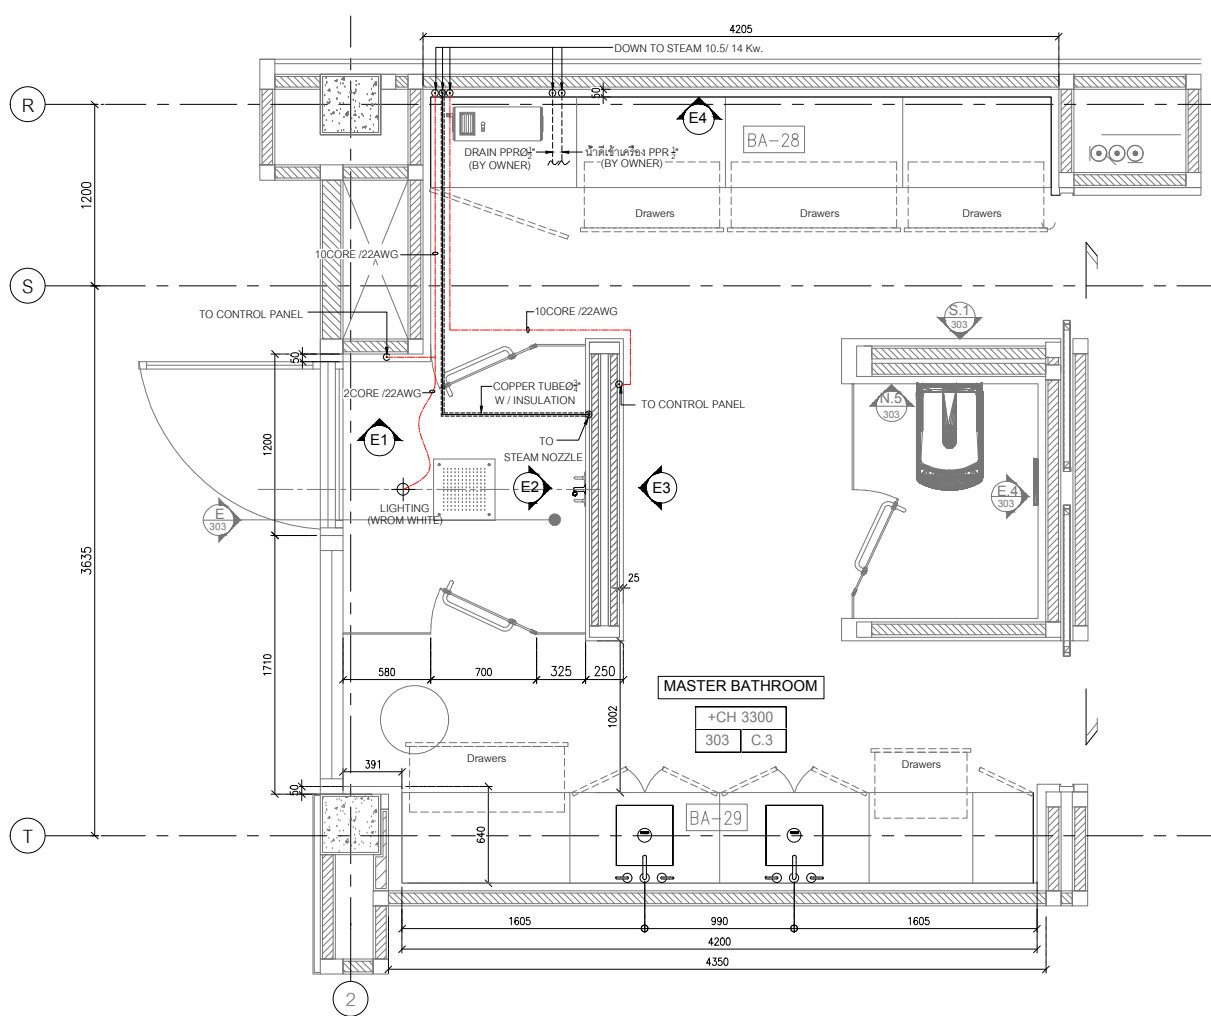


MASTER BATHROOM CEILING PLAN
SCALE 1:50

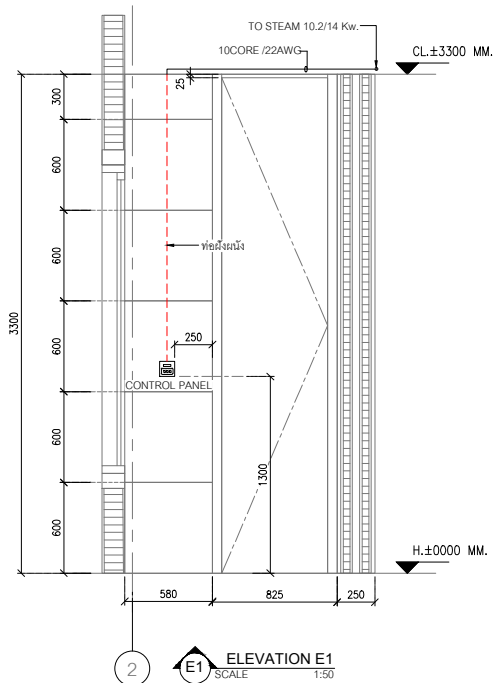


E1 ELEVATION E1
SCALE 1:50

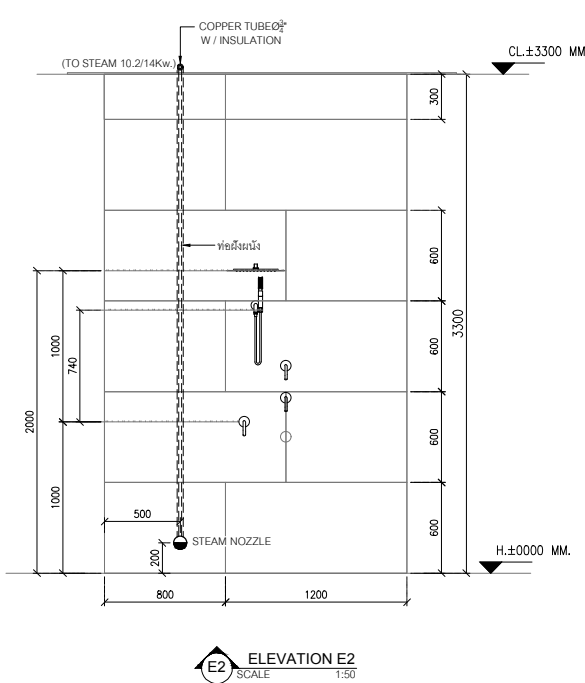

E2 ELEVATION E2
SCALE 1:50

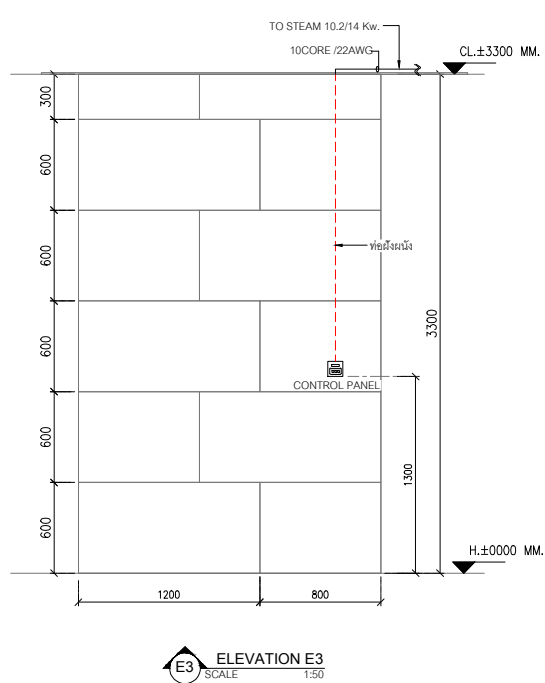

E3 ELEVATION E3
SCALE 1:50

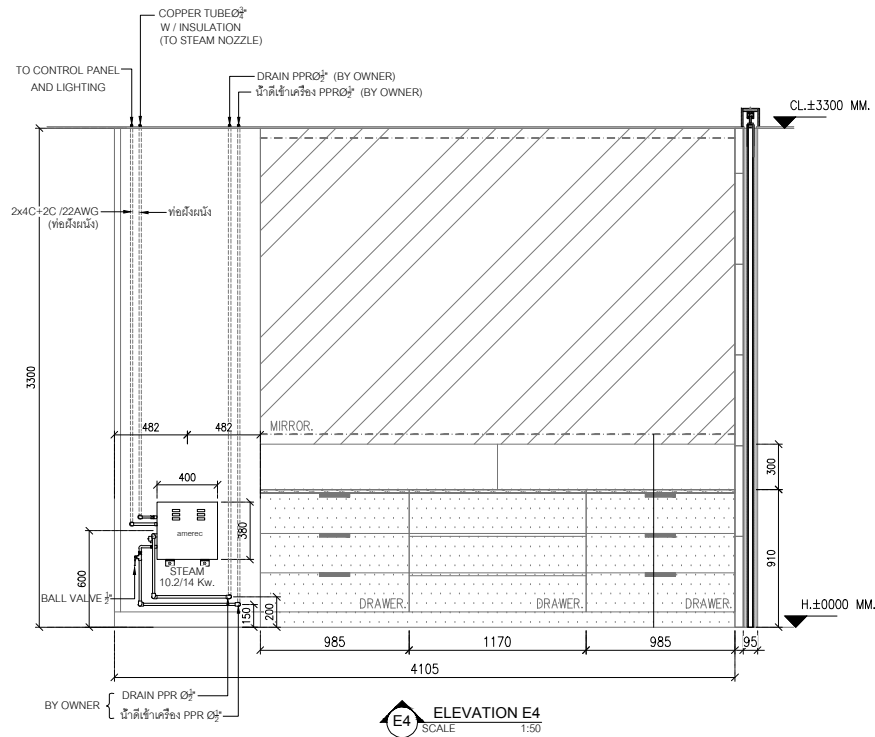

E4 ELEVATION E4
SCALE 1:50