


ARCHITECT

STRUCTURAL ENGINEER

SANITARY ENGINEER

ELECTRICAL ENGINEER

NOTE.

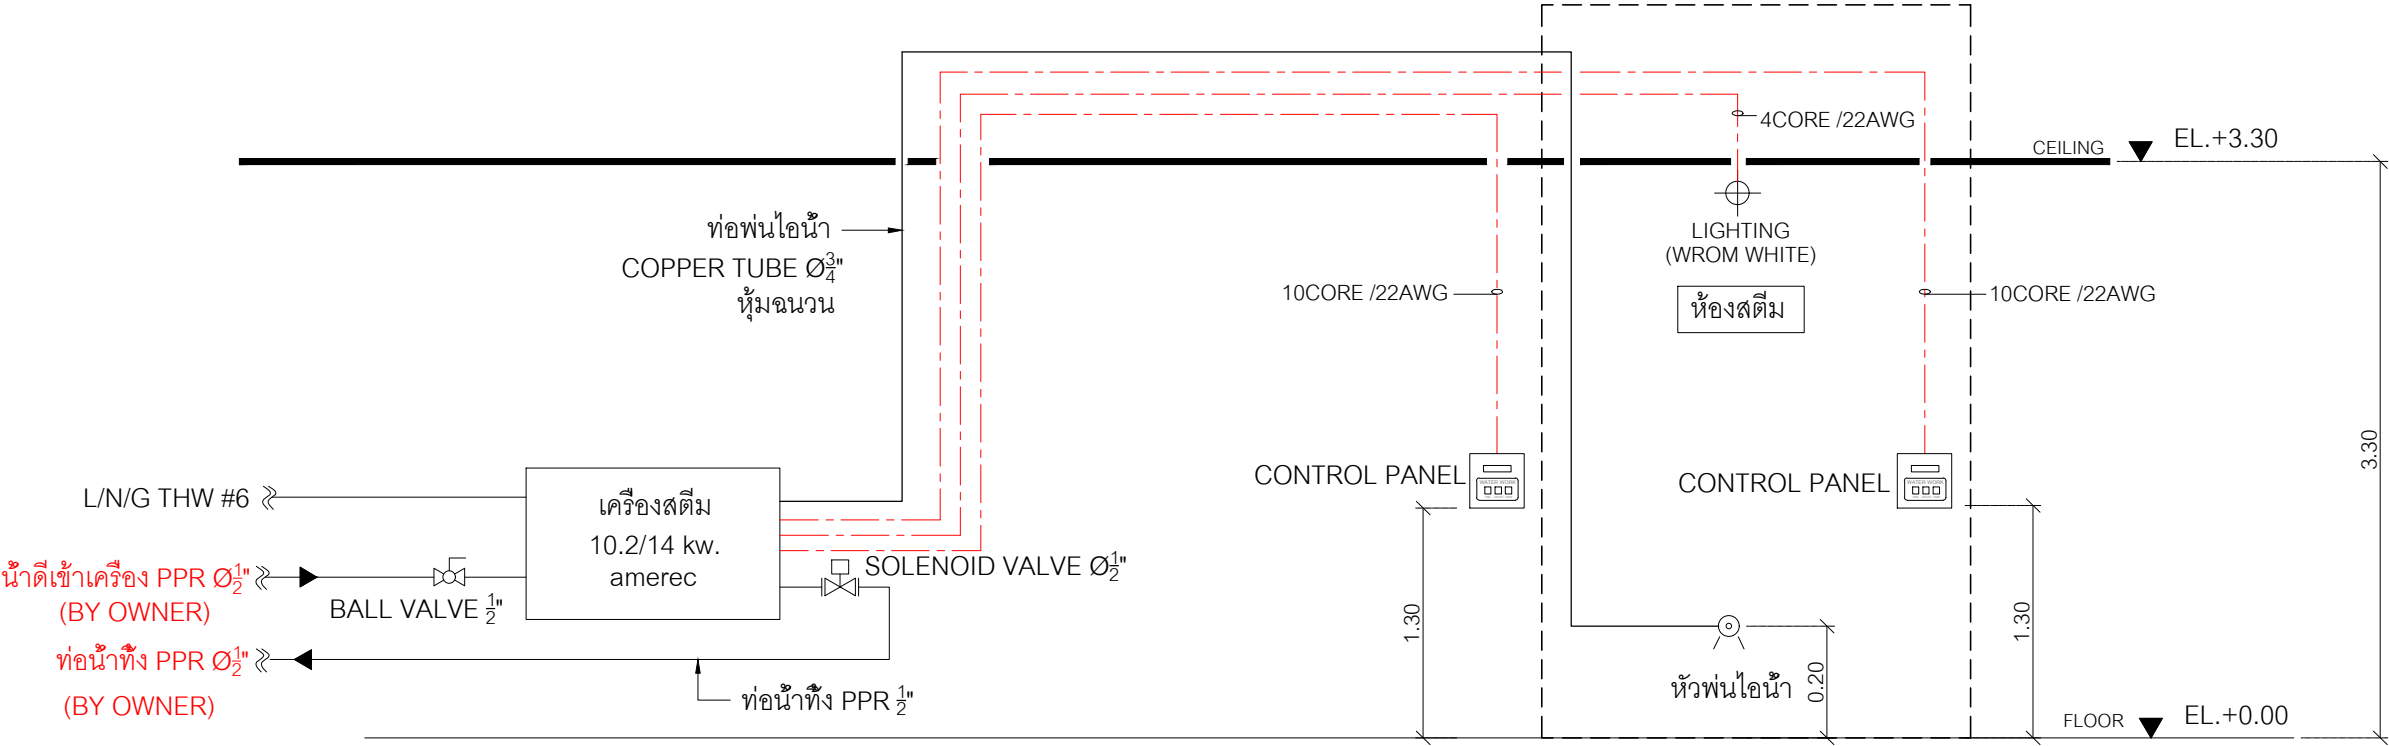

SINGLE LINE DIAGRAM

REVISION		
NO.	DATE	DESCRIPTION
00	3/2/2565	FOR APPROVAL
PROJECT		
RS HOUSE ZONE A STEAM ROOM SYSTEM (14Kw.)		
TITLE		
SINGLE LINE DIAGRAM		
APPROVAL BY		
DRAWN BY		
นายสมศักดิ์ แสงมณี		
SCALE	1:50	DATE 25/03/2565
DWG. NO.	S-02	TOTAL