

CASA
TECH
ENGINEERED FOR YOUR WELL-LIVING

Casa Tech Co.,Ltd
100/68 Room G
Soi Sukhumvit 26 Klongtoei, Klongtoei
Bangkok 10110 Tel. +66 2 261 940

ARCHITECT

STRUCTURAL ENGINEER

SANITARY ENGINEER

ELECTRICAL ENGINEER

NOTE:

REVISION		
NO.	DATE	DESCRIPTION
00	1/4/2568	FOR APPROVAL
01	28/4/2568	FOR APPROVAL

PROJECT

SAUNA AND STEAM ROOM

TITLE

SINGLE LINE DIAGRAM


APPROVAL BY

DRAWN BY

นายสมศักดิ์ แสงมณี

SCALE	DATE
1:50	1/4/2568

DWG. NO.	TOTAL
ME01	

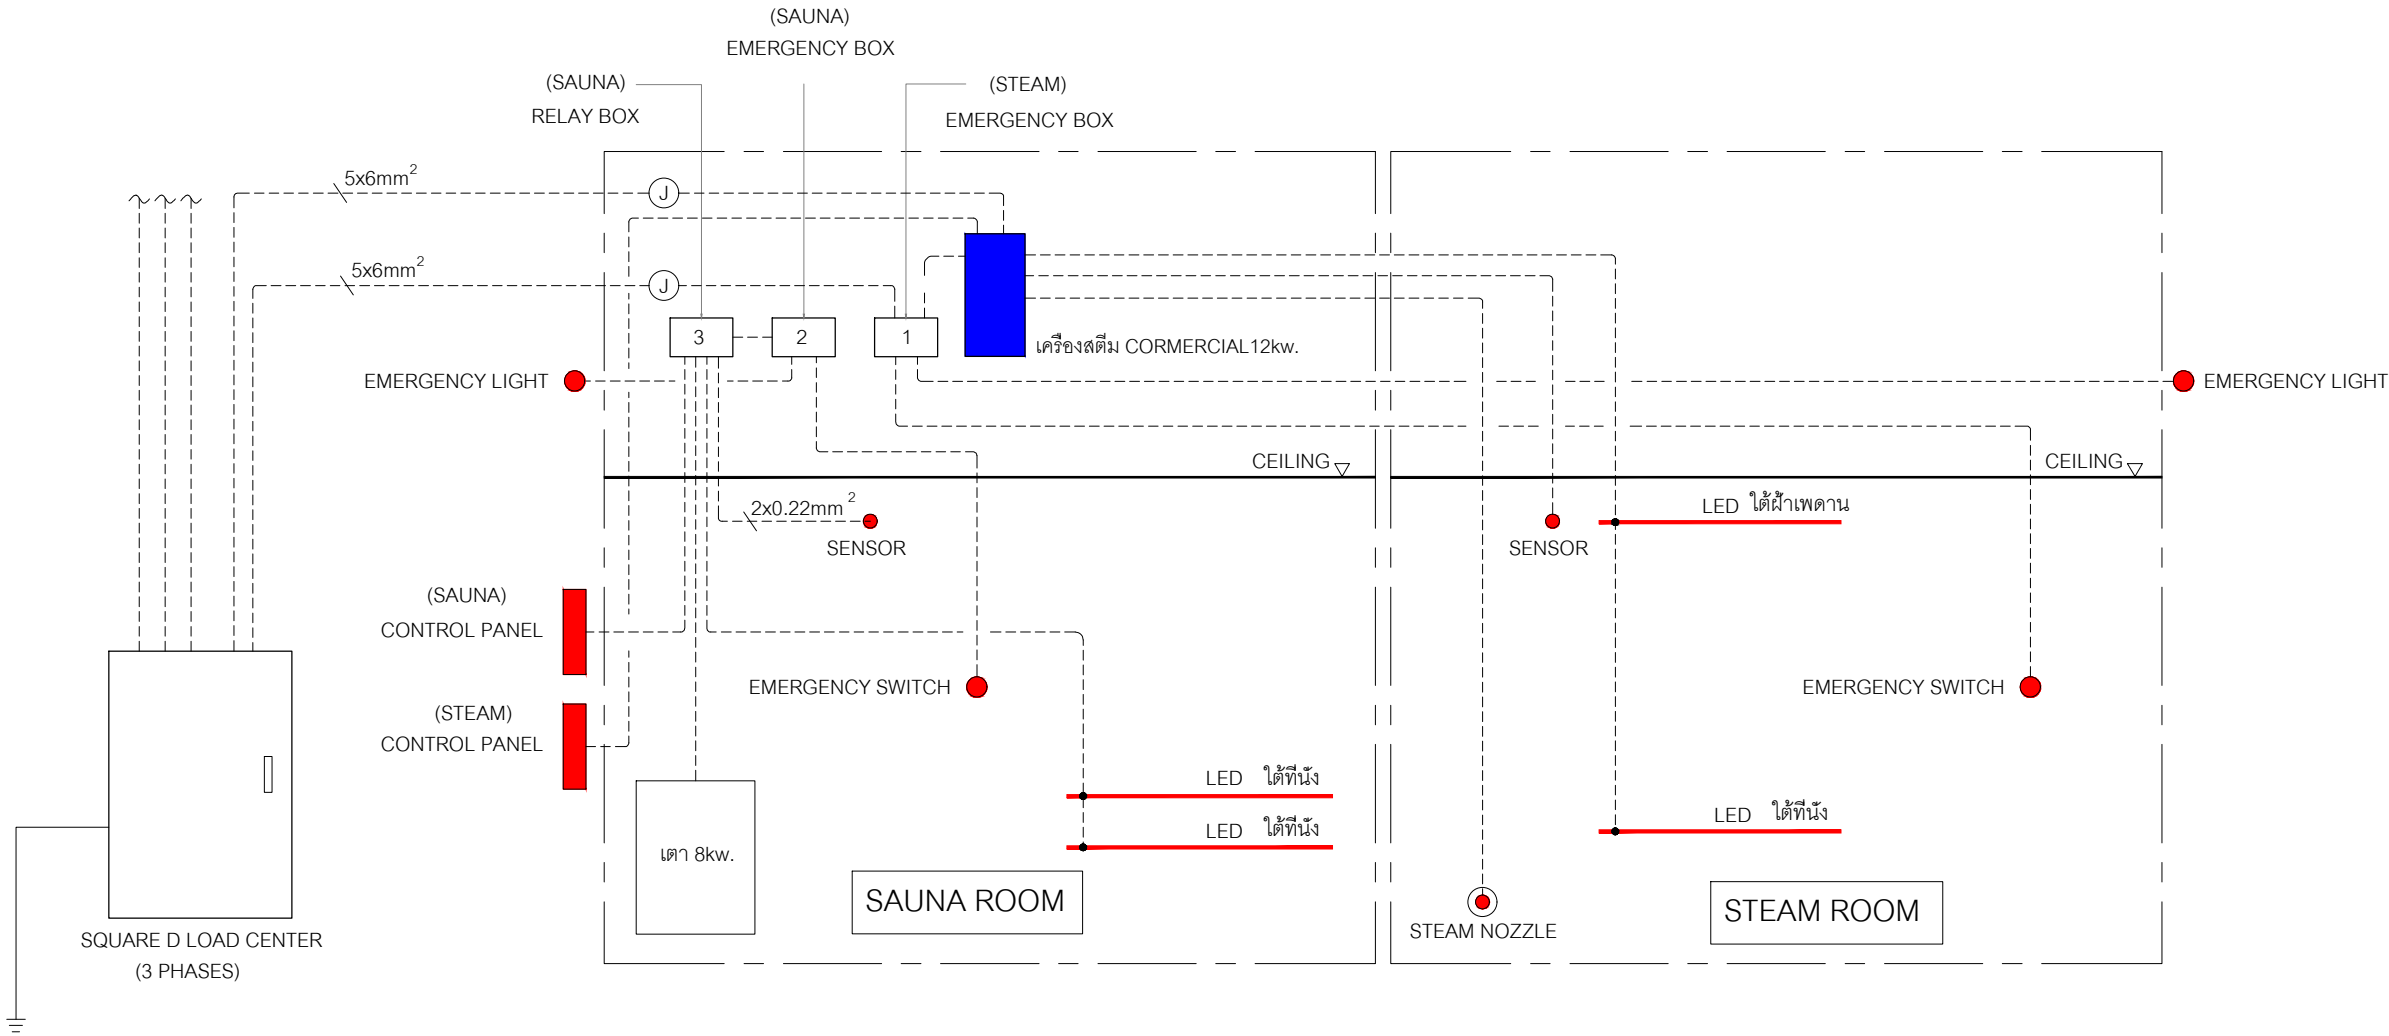

SINGLE LINE DIAGRAM : MALE TOILET, FEMALE TOILET

ARCHITECT

STRUCTURAL ENGINEER

SANITARY ENGINEER

ELECTRICAL ENGINEER

NOTE.

PROJECT

SAUNA AND STEAM ROOM
(MALE)

TITLE

LAYOUT PLAN

APPROVAL BY

DRAWN BY

นายสมศักดิ์ แสงมณี

SCALE
1:25


DATE
1/4/2568

DWG. NO.

TOTAL

ME02

TOTAL

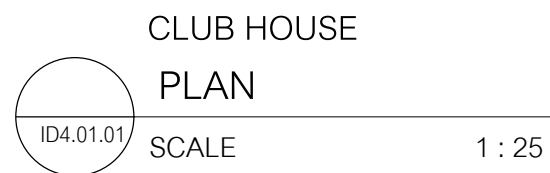

CASA
TECH

ENGINEERED FOR YOU, A WELL-LIVING

Casa Tech Co.,Ltd

100/68 Room G

Soi Sukhumvit 26 Klongtoei, Klongtoei

Bangkok 10110 Tel. +66 2 261 940

ARCHITECT

STRUCTURAL ENGINEER

SANITARY ENGINEER

ELECTRICAL ENGINEER

NOTE.

REVISION		
NO.	DATE	DESCRIPTION
00	1/4/2568	FOR APPROVAL
01	28/4/2568	FOR APPROVAL

PROJECT

SAUNA AND STEAM ROOM

(MALE)

TITLE

ELEVATION E


APPROVAL BY

DRAWN BY

นายสมศักดิ์ แสงมณี

SCALE	DATE
1:25	1/4/2568

DWG. NO.	TOTAL
ME03	

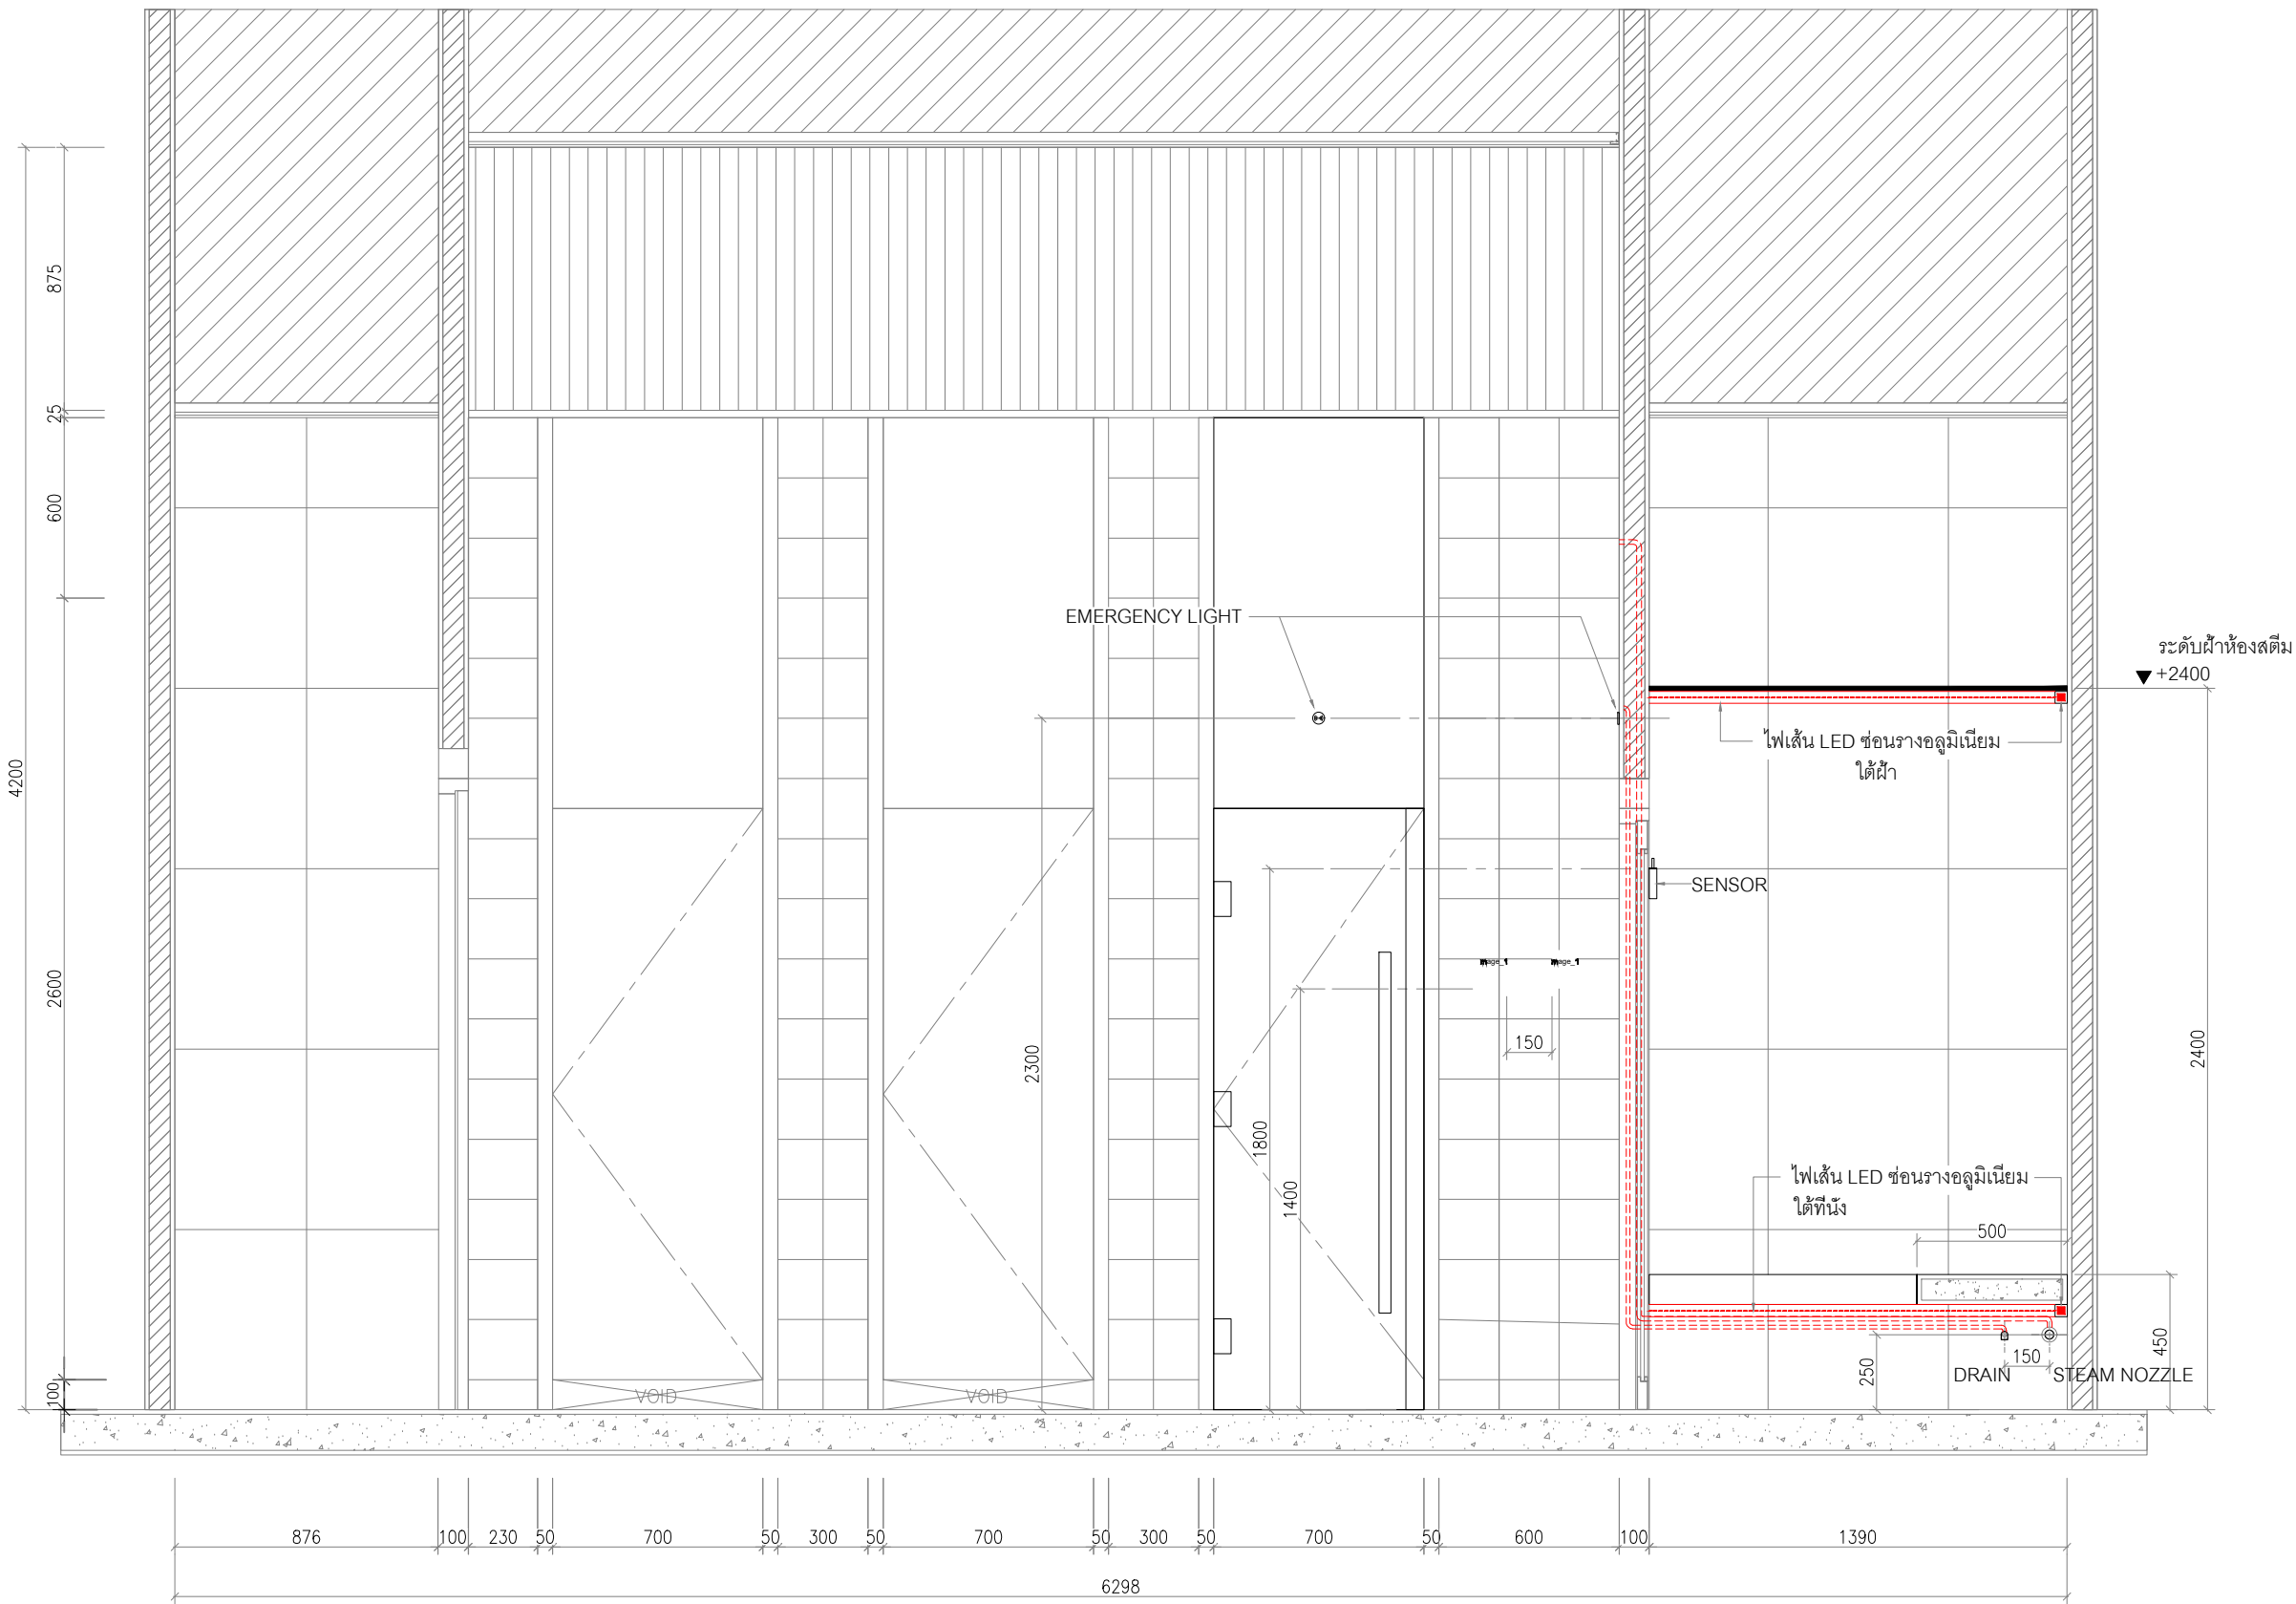

CLUB HOUSE
ELEVATION
SCALE 1 : 25



Casa Tech Co.,Ltd
100/68 Room G
Soi Sukhumvit 26 Klongtoei, Klongtoei
Bangkok 10110 Tel. +66 2 261 940

ARCHITECT

STRUCTURAL ENGINEER

SANITARY ENGINEER

ELECTRICAL ENGINEER

NOTE:

REVISION		
NO.	DATE	DESCRIPTION
00	1/4/2568	FOR APPROVAL
01	28/4/2568	FOR APPROVAL

PROJECT
SAUNA AND STEAM ROOM
(MALE)


TITLE
ELEVATION F

APPROVAL BY

DRAWN BY
นายสมศักดิ์ แสงมณี

SCALE 1:25	DATE 1/4/2568
---------------	------------------

DWG. NO. ME04	TOTAL
------------------	-------

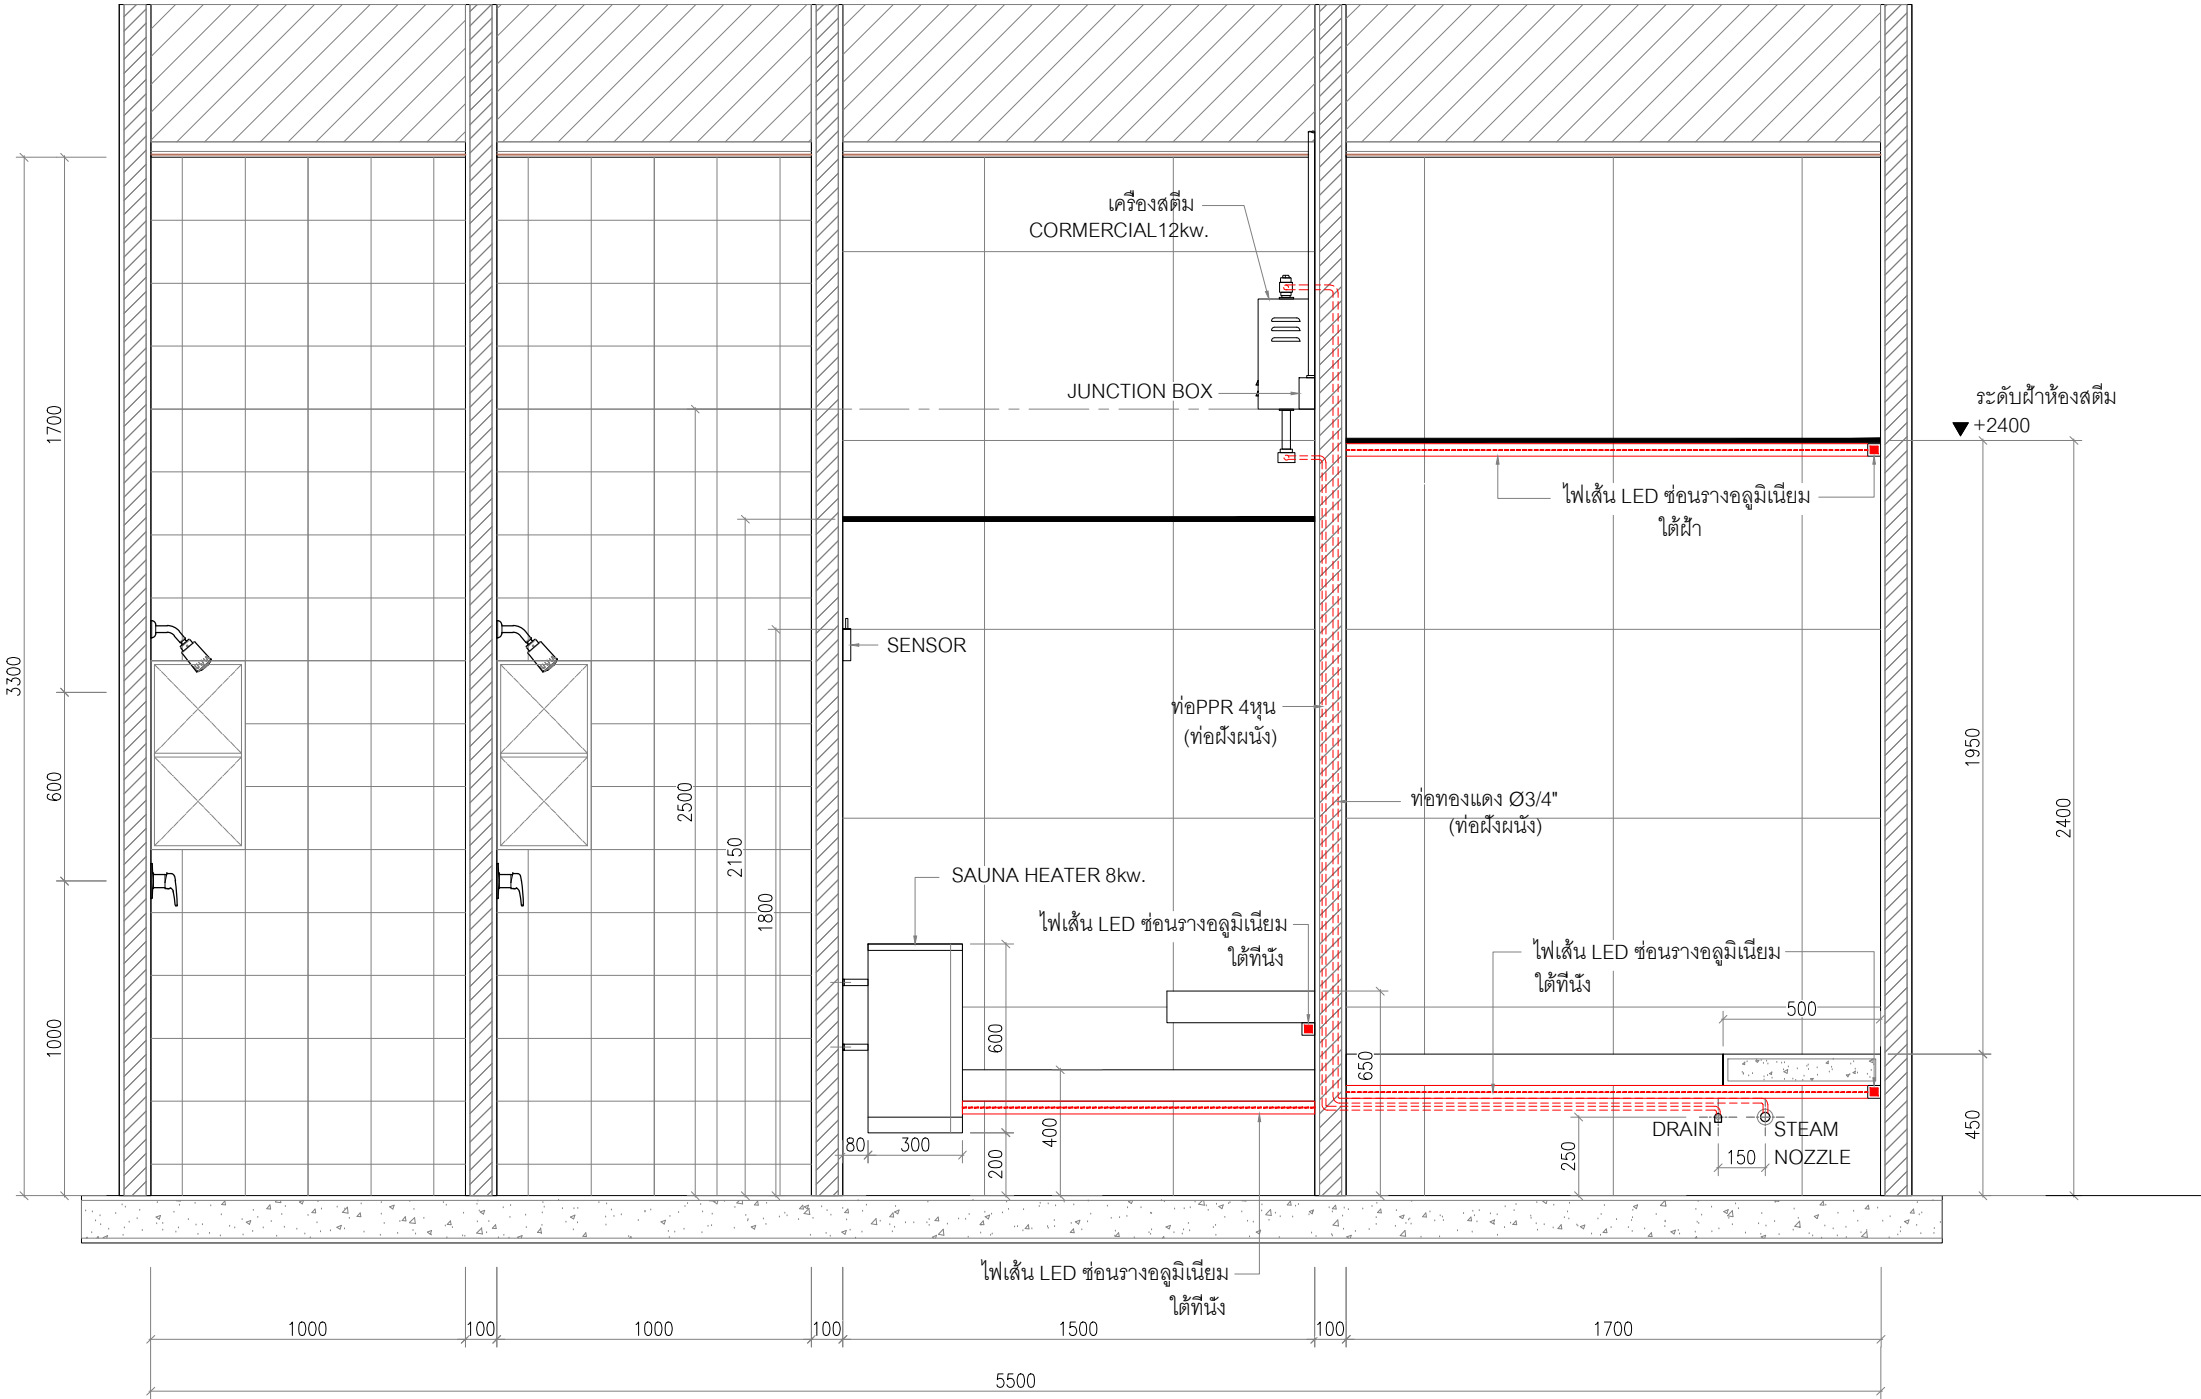

CLUB HOUSE
ELEVATION
SCALE 1 : 25



ARCHITECT

STRUCTURAL ENGINEER

SANITARY ENGINEER

ELECTRICAL ENGINEER

NOTE.

PROJECT

SAUNA AND STEAM ROOM

(MALE)

TITLE

ELEVATION F

APPROVAL BY _____

DRAWN BY

นายสมศักดิ์ แสงมณี

SCALE
1:25

1/4/2568

DWG. NO.

TOTAL

ME05



CASA
TECH

ENGINEERED FOR YOU, A WELL-LIVING

Casa Tech Co.,Ltd

100/68 Room G

Soi Sukhumvit 26 Klongtoei, Klongtoei

Bangkok 10110 Tel. +66 2 261 940

ARCHITECT

STRUCTURAL ENGINEER

SANITARY ENGINEER

ELECTRICAL ENGINEER

NOTE:

REVISION		
NO.	DATE	DESCRIPTION
00	1/4/2568	FOR APPROVAL
01	28/4/2568	FOR APPROVAL

PROJECT

SAUNA AND STEAM ROOM
(FEMALE)

TITLE

LAYOUT PLAN


APPROVAL BY

DRAWN BY

นายสมศักดิ์ แสงมณี

SCALE	DATE
1:25	1/4/2568

DWG. NO.	TOTAL
ME06	

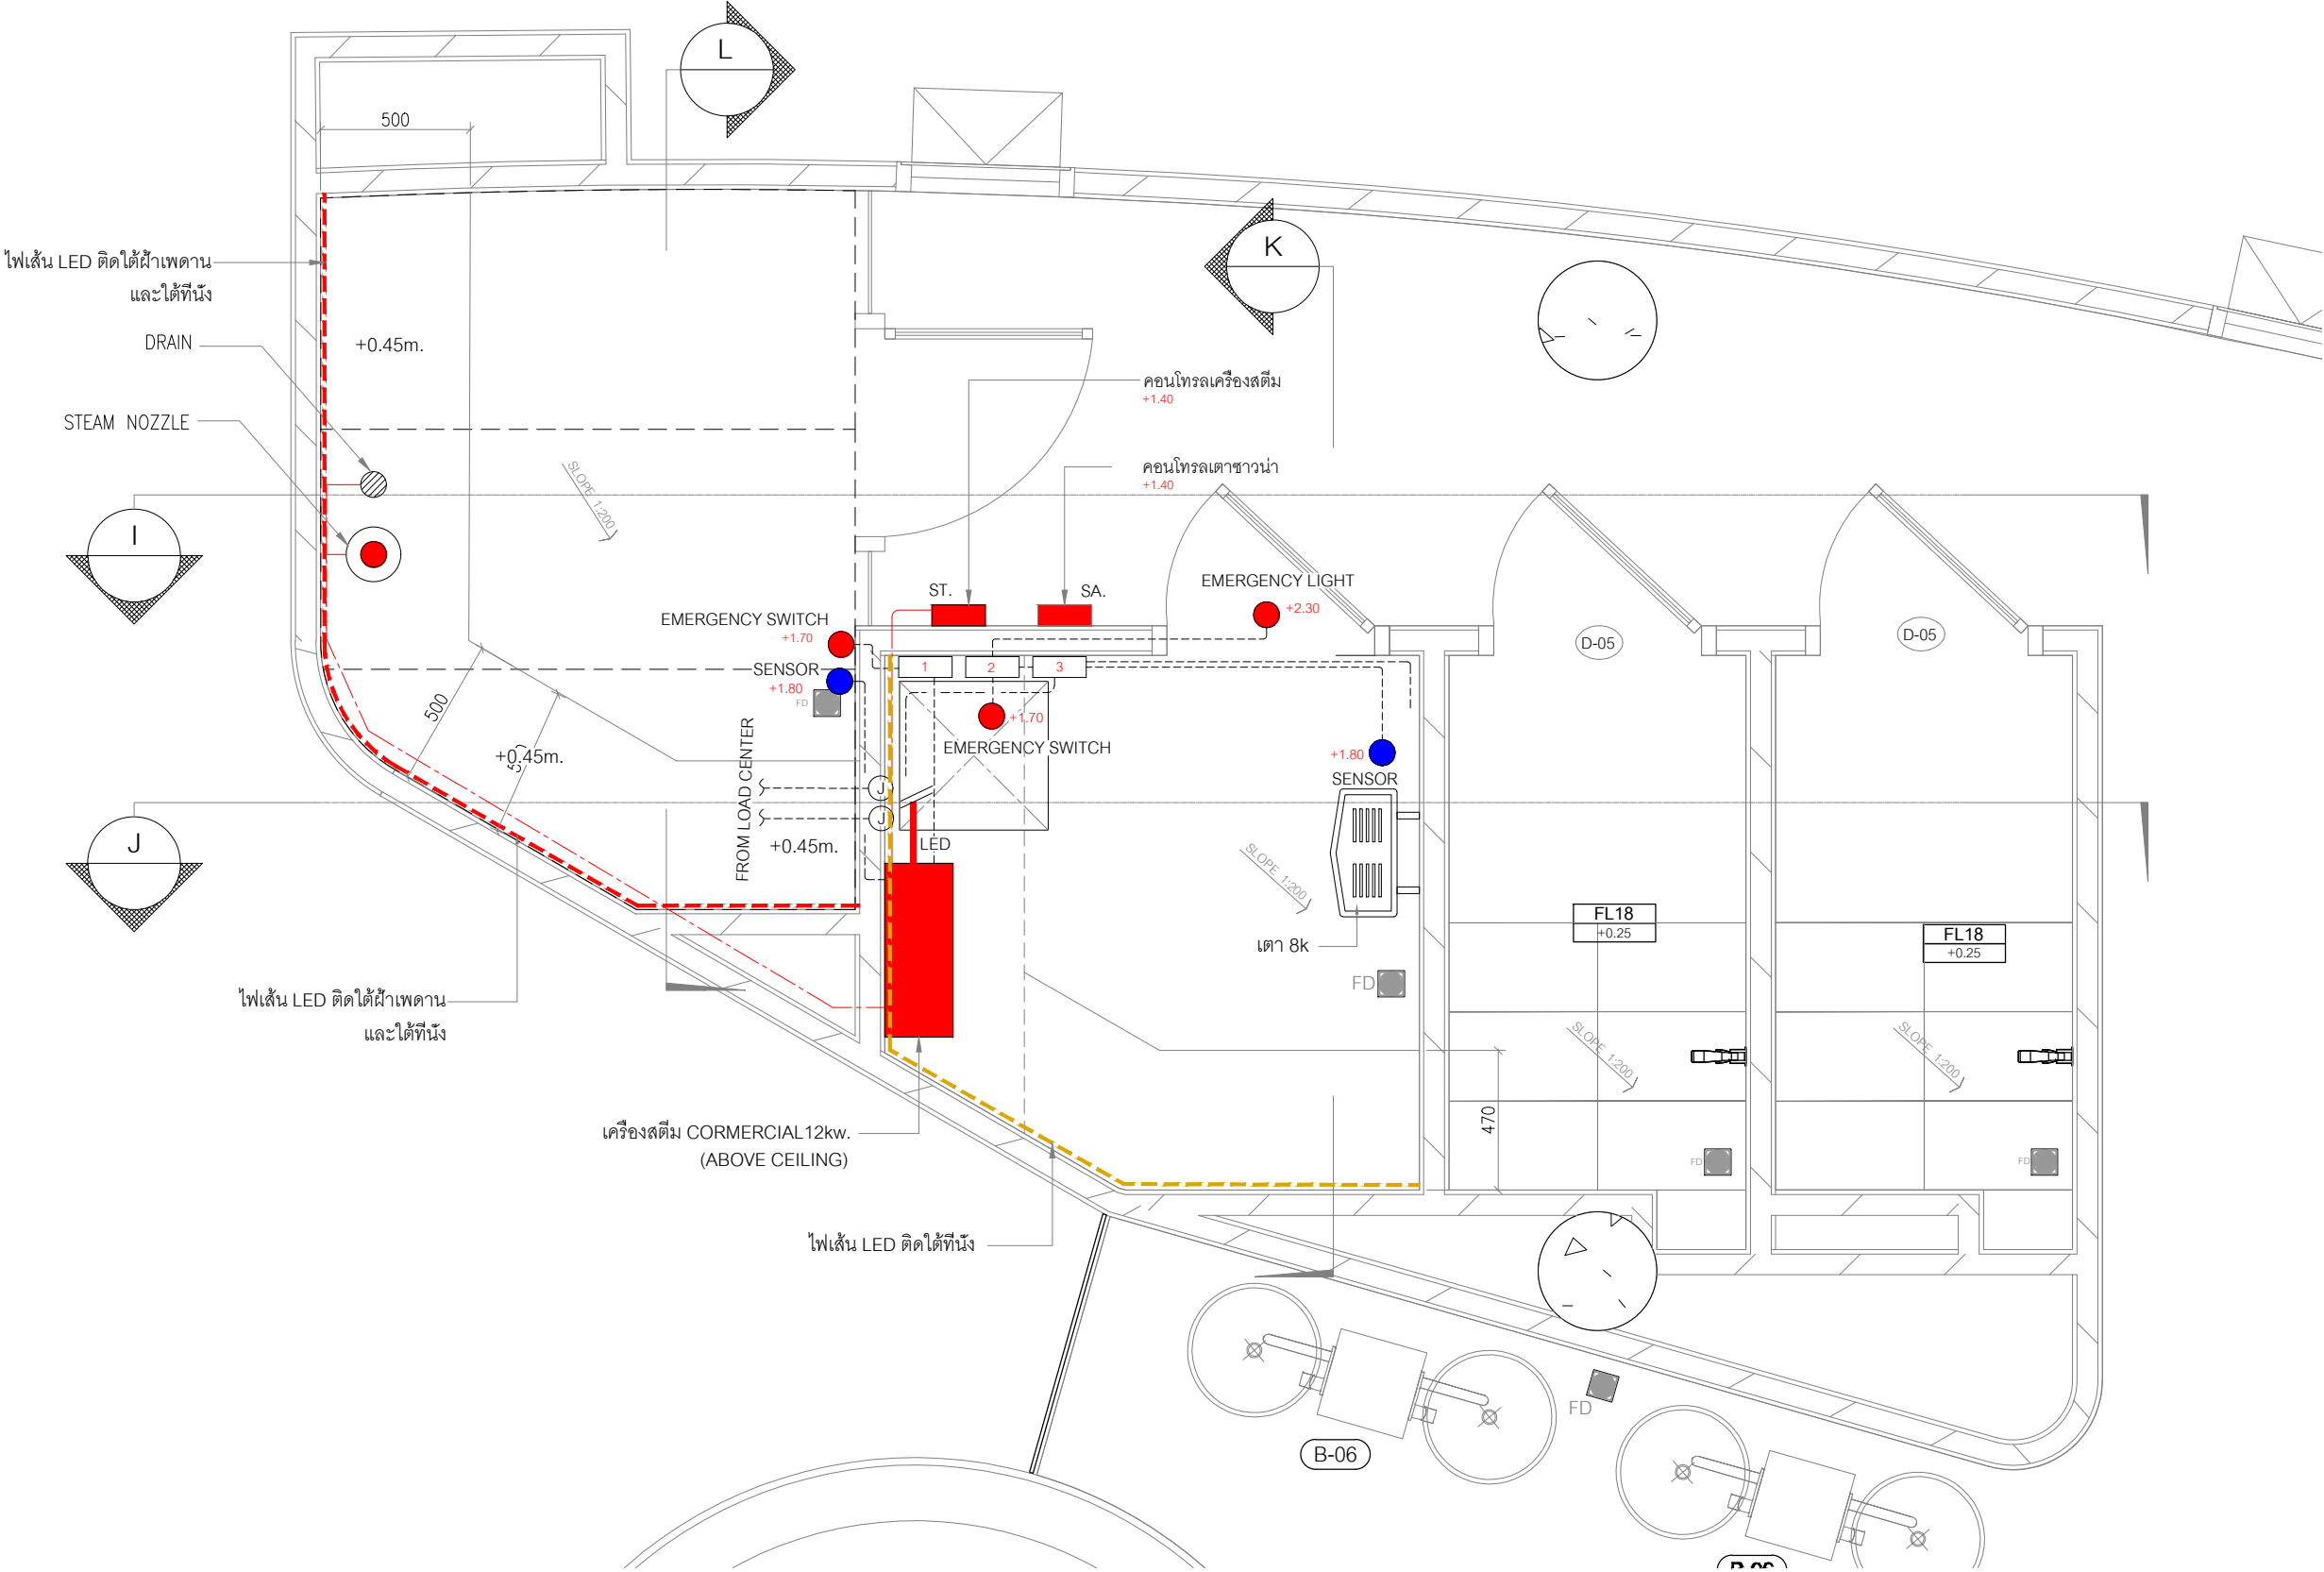

CASA
TECH

ENGINEERED FOR YOU, A WELL-LIVING

Casa Tech Co.,Ltd

100/68 Room G

Soi Sukhumvit 26 Klongtoei, Klongtoei

Bangkok 10110 Tel. +66 2 261 940

ARCHITECT

STRUCTURAL ENGINEER

SANITARY ENGINEER

ELECTRICAL ENGINEER

NOTE:

REVISION		
NO.	DATE	DESCRIPTION
00	1/4/2568	FOR APPROVAL
01	28/4/2568	FOR APPROVAL

PROJECT

SAUNA AND STEAM ROOM
(FEMALE)

TITLE

LAYOUT PLAN


APPROVAL BY

DRAWN BY

นายสมศักดิ์ แสงมณี

SCALE	DATE
1:25	1/4/2568

DWG. NO.	TOTAL
ME07	

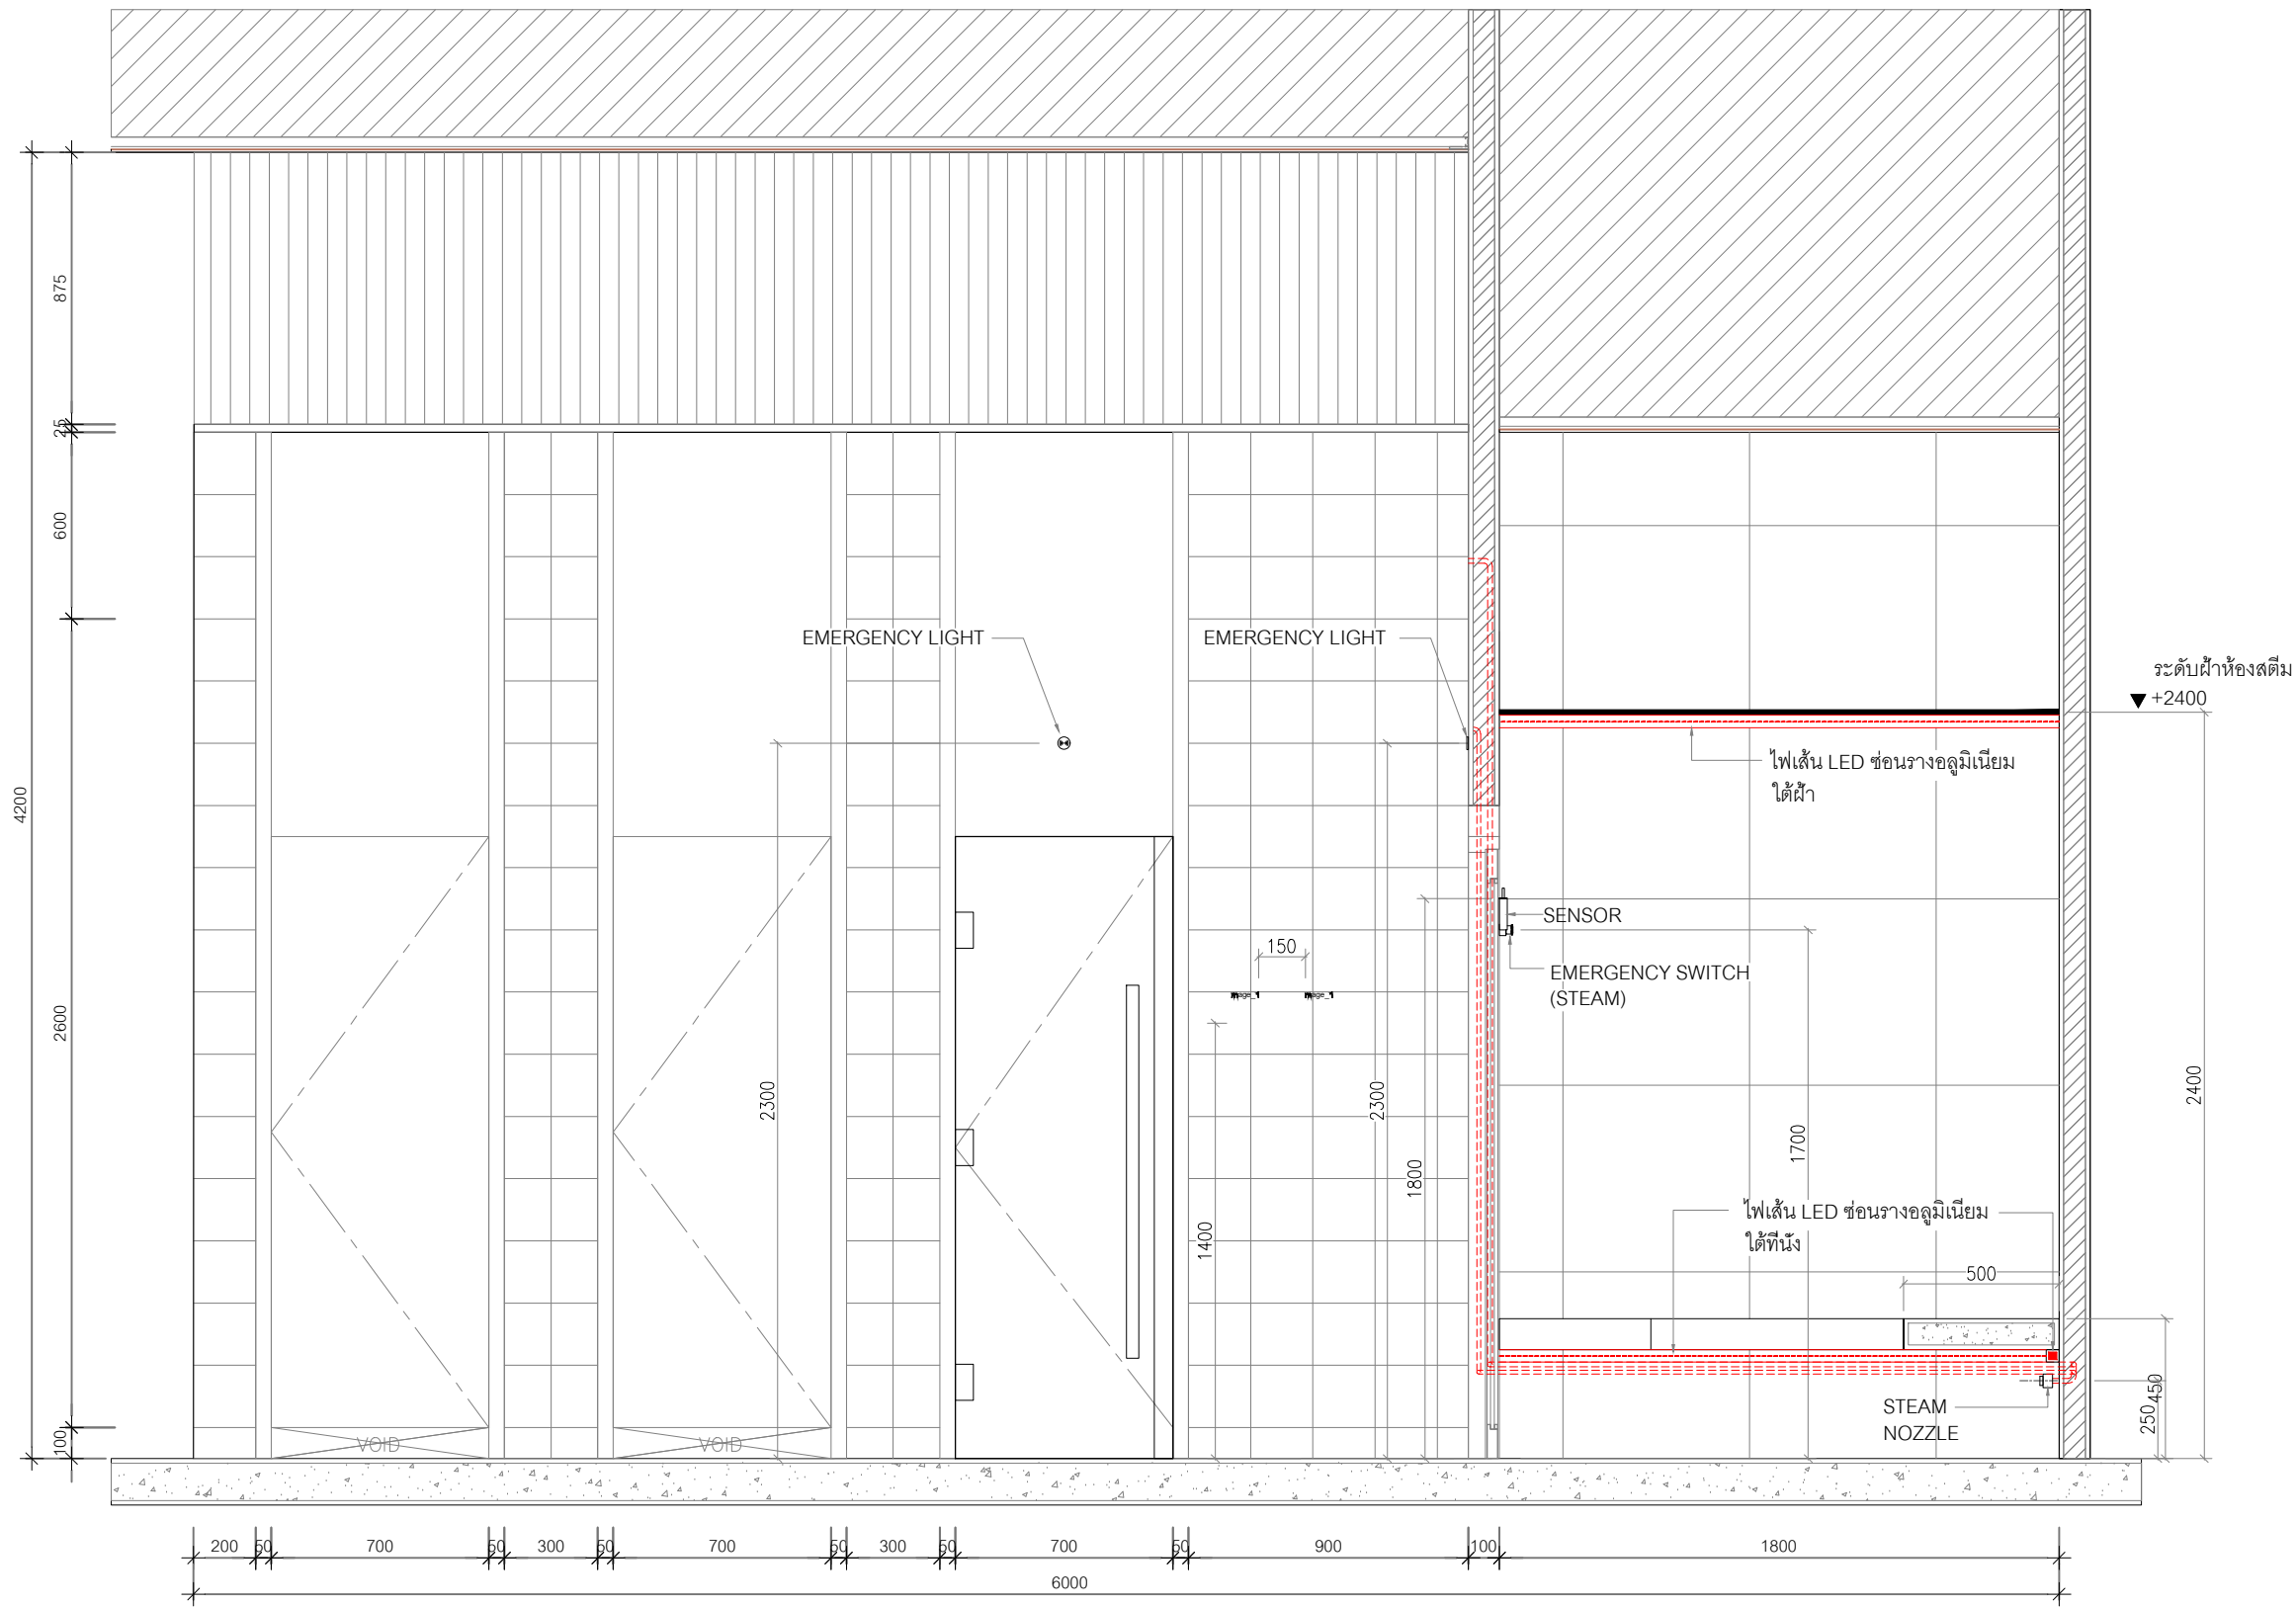

CLUB HOUSE
ELEVATION
SCALE 1 : 25



ARCHITECT

STRUCTURAL ENGINEER

SANITARY ENGINEER

ELECTRICAL ENGINEER

NOTE.

REVISION		
NO.	DATE	DESCRIPTION
00	1/4/2568	FOR APPROVAL
01	28/4/2568	FOR APPROVAL

PROJECT

SAUNA AND STEAM ROOM
(FEMALE)

TITLE

LAYOUT PLAN

APPROVAL BY _____

DRAWN BY

นายสมศักดิ์ แสงมณี

SCALE
1:25


1/4/2568

DWG. NO.

TOTAL

ME08


TOTAL

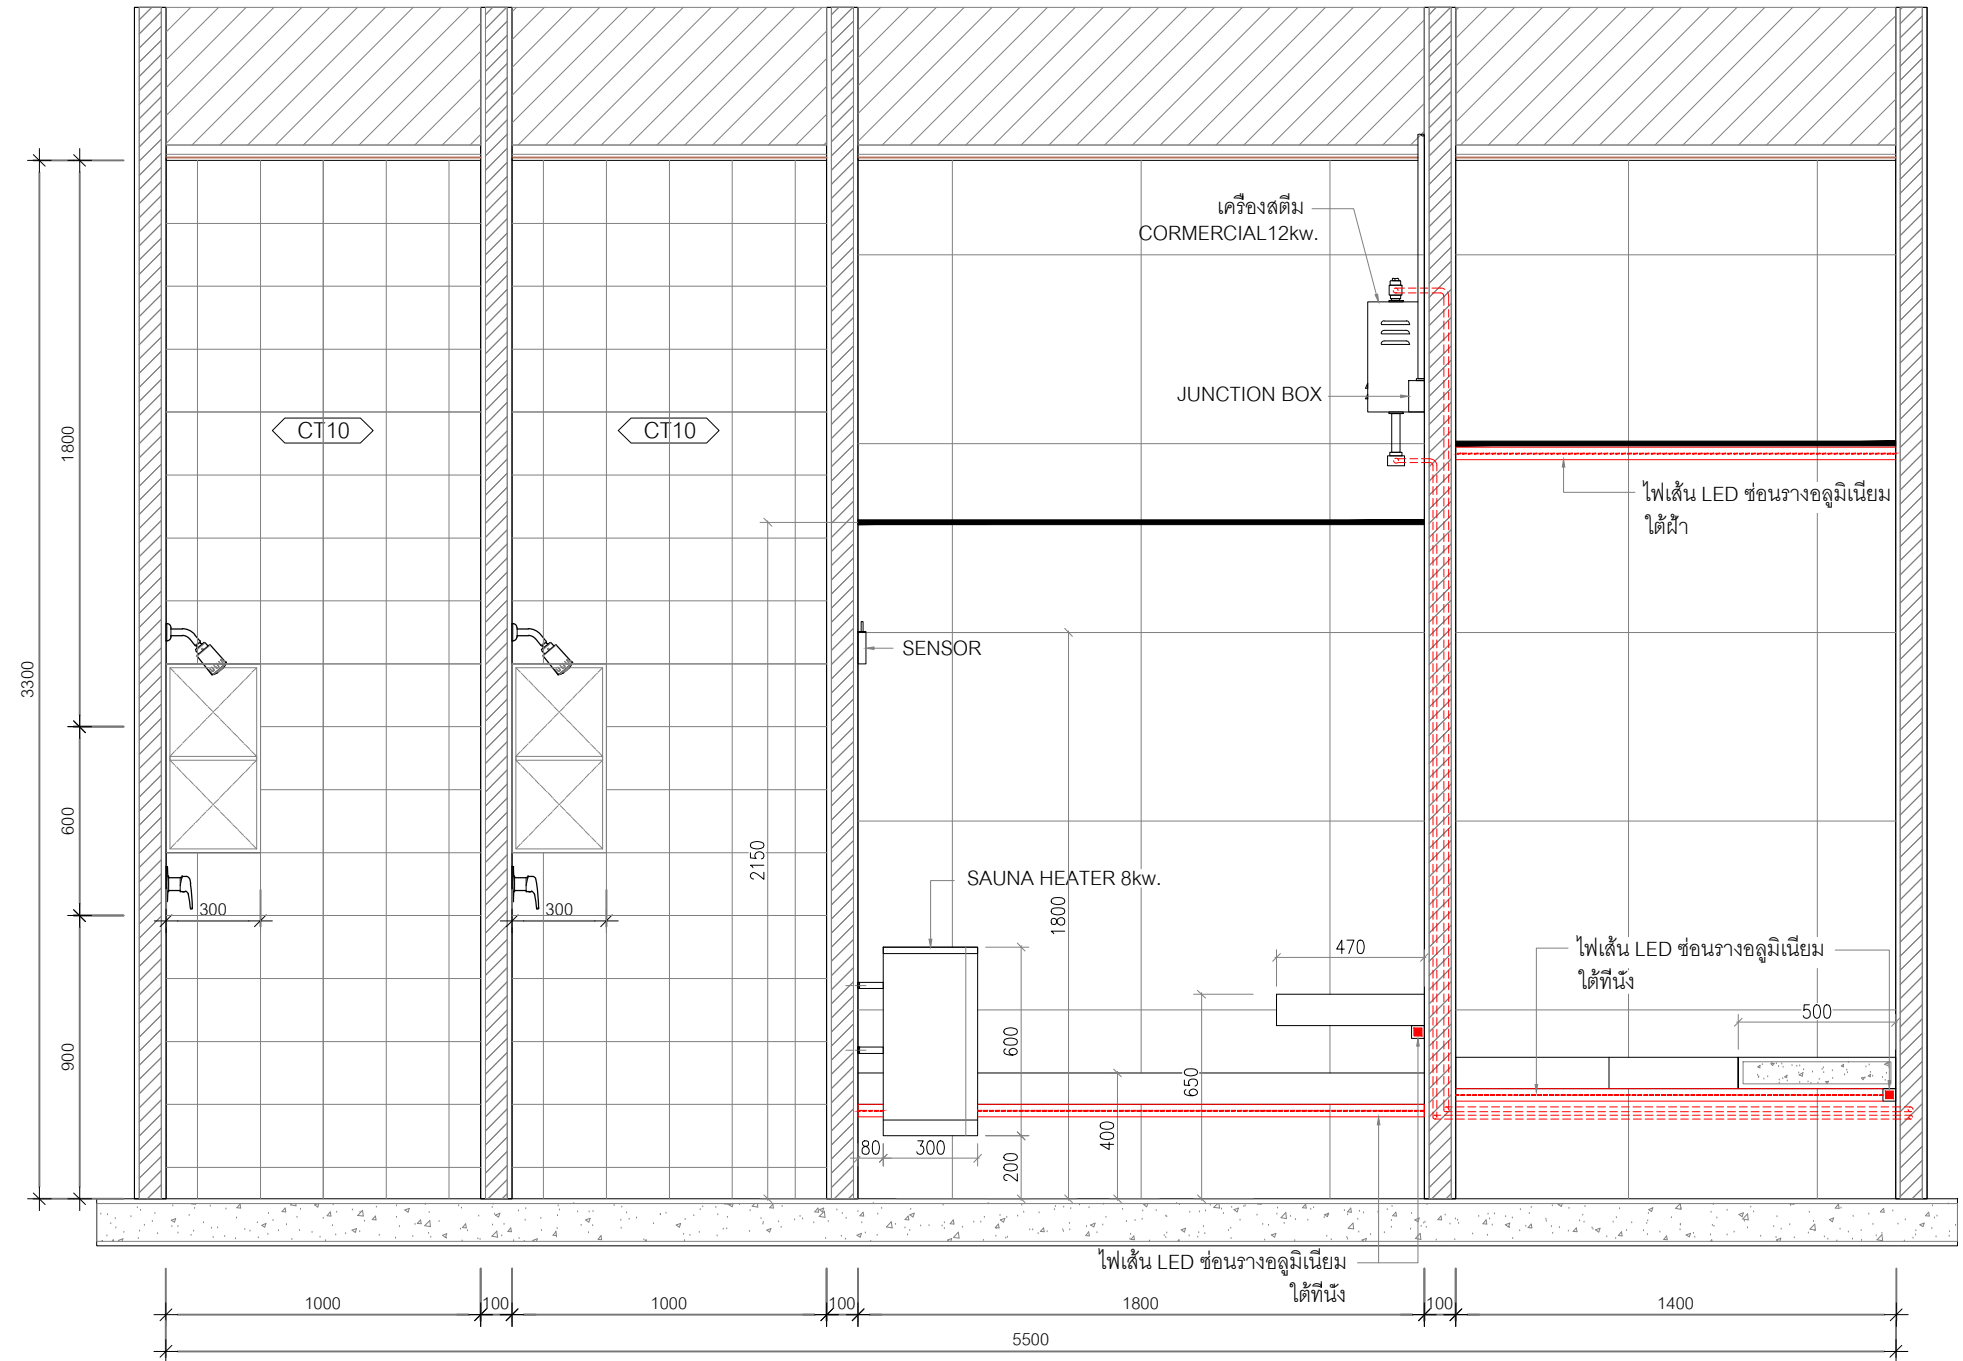

CLUB HOUSE ELEVATION

SCALE

1 : 25

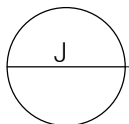

CASA
TECH

ENGINEERED FOR YOU & WELL-LIVING

Casa Tech Co.,Ltd

100/68 Room G

Soi Sukhumvit 26 Klongtoei, Klongtoei

Bangkok 10110 Tel. +66 2 261 940

ARCHITECT

STRUCTURAL ENGINEER

SANITARY ENGINEER

ELECTRICAL ENGINEER

NOTE:

REVISION		
NO.	DATE	DESCRIPTION
00	1/4/2568	FOR APPROVAL
01	28/4/2568	FOR APPROVAL

PROJECT

SAUNA AND STEAM ROOM
(FEMALE)

TITLE

ELEVATION F


APPROVAL BY

DRAWN BY

นายสมศักดิ์ แสงมณี

SCALE	DATE
1:25	1/4/2568


DWG. NO.	TOTAL
ME09	

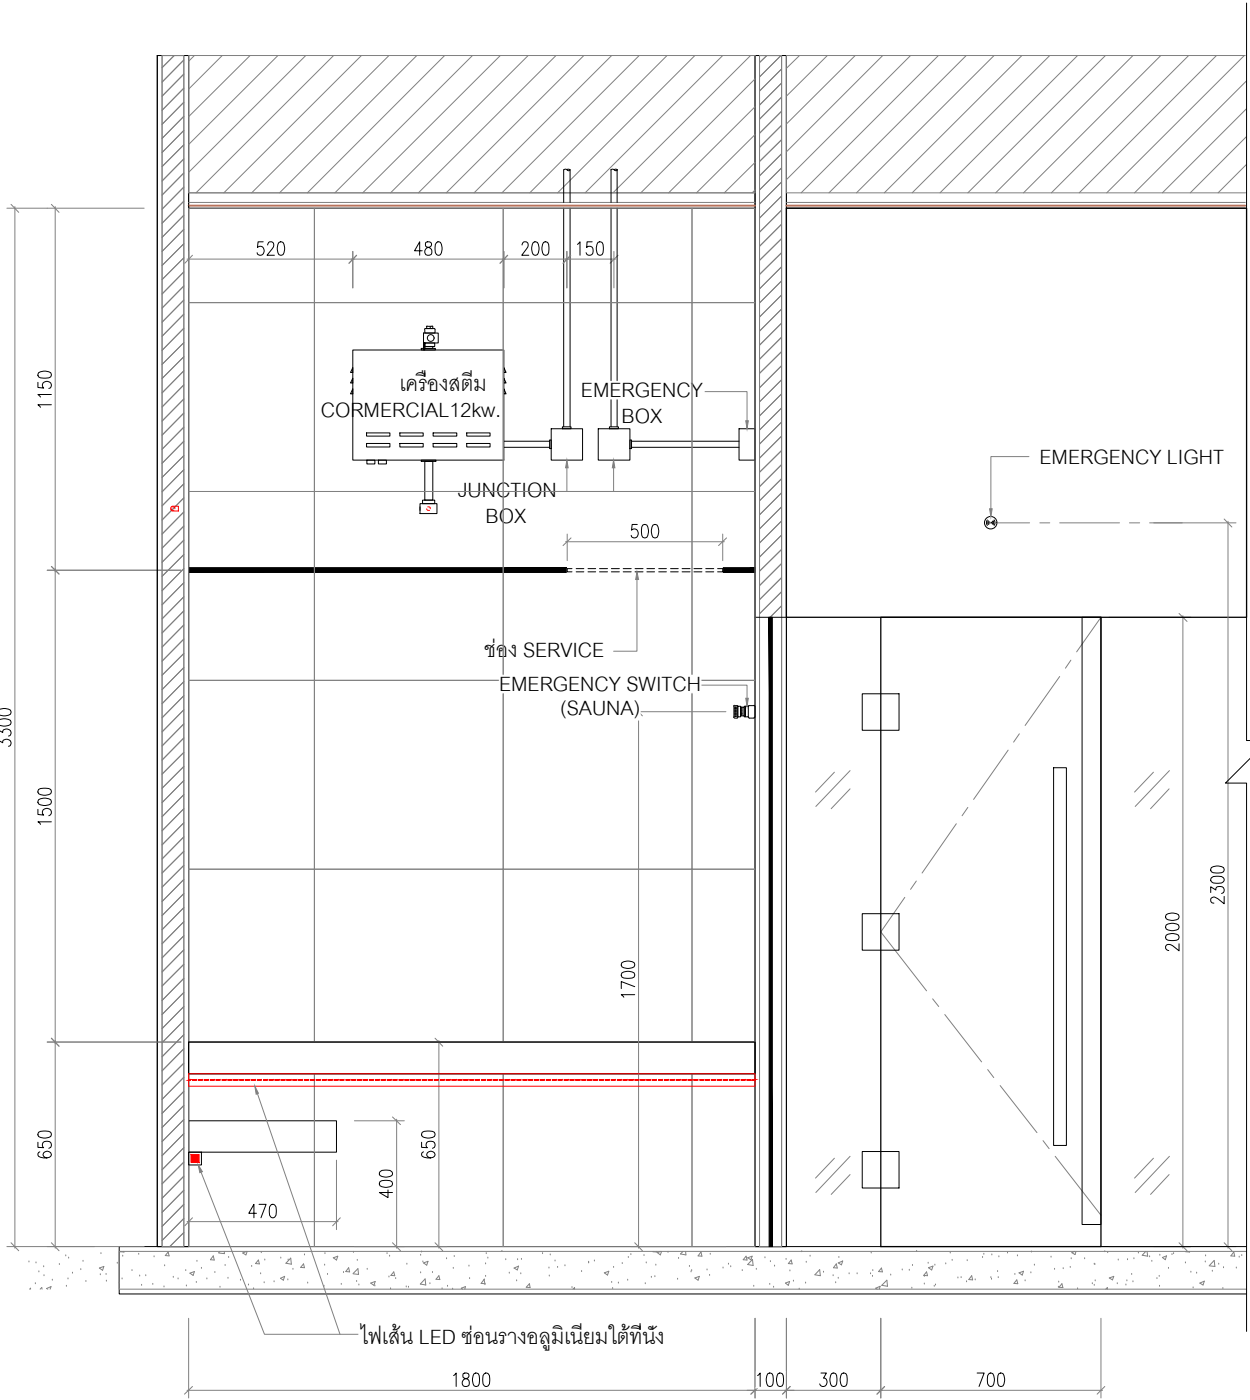

K

CLUB HOUSE
ELEVATION


SCALE 1 : 25

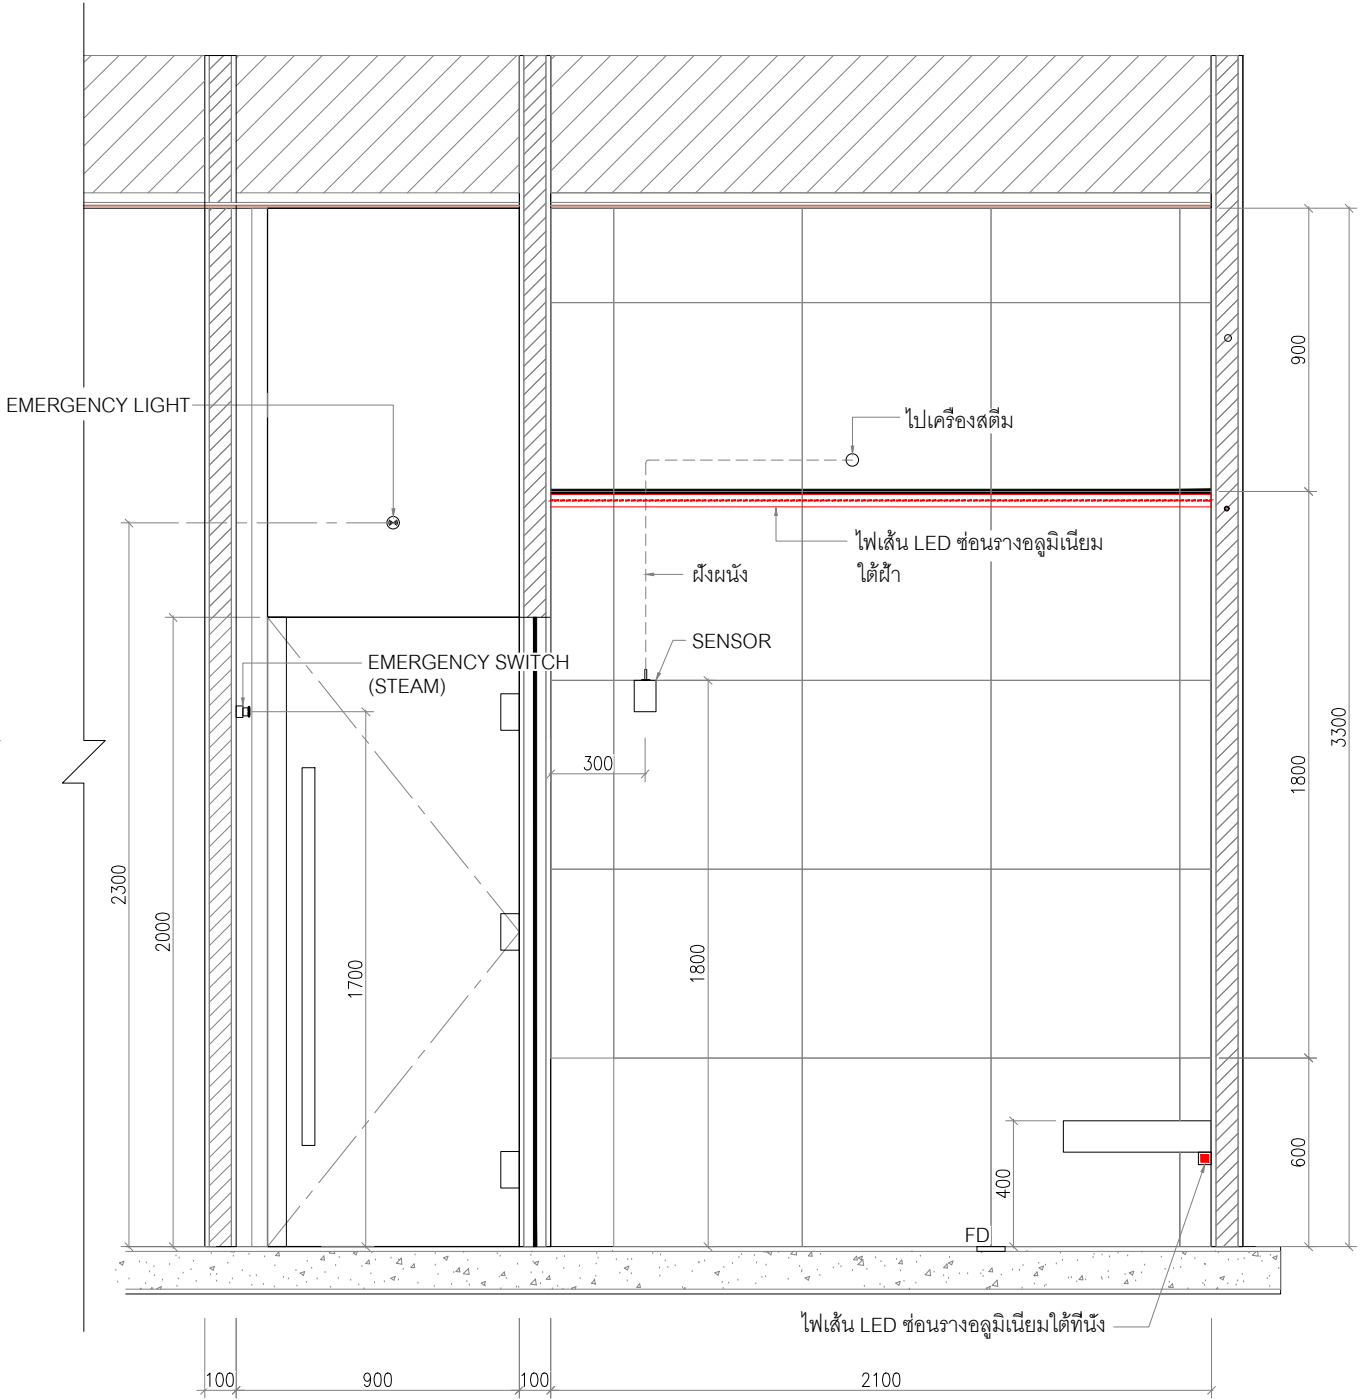


L

CLUB HOUSE
ELEVATION

SCALE 1 : 25

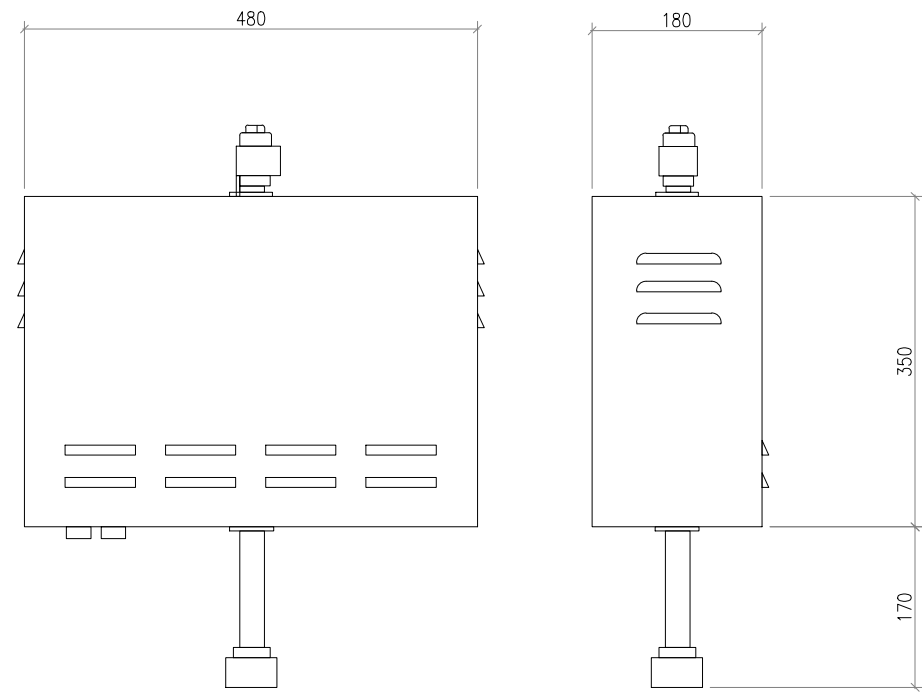

เครื่องสตีม CORMERCIAL 12kw.

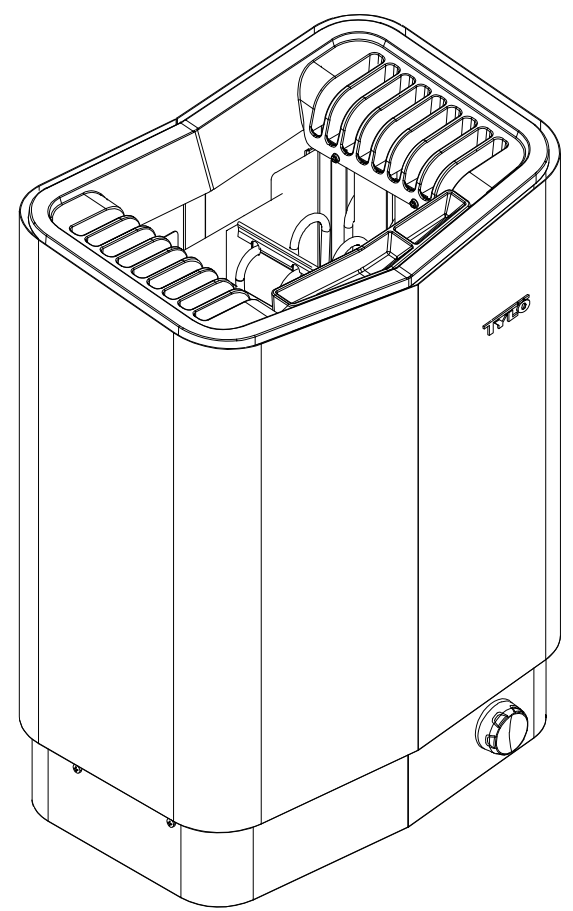

SAUNA HEATER



Bild 2

INSTALLATION OF CONTROL PANEL

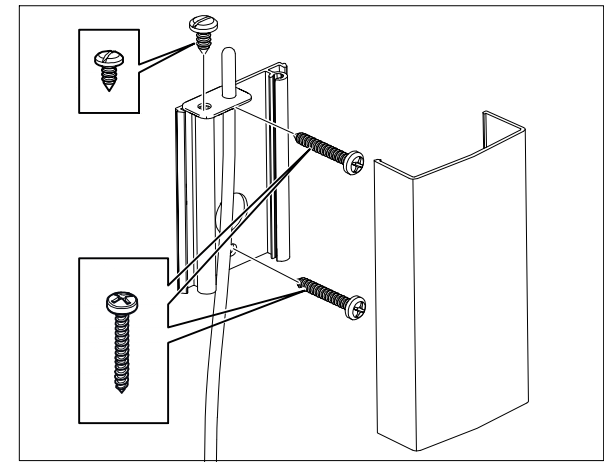


Fig 15: Montering av sensorn


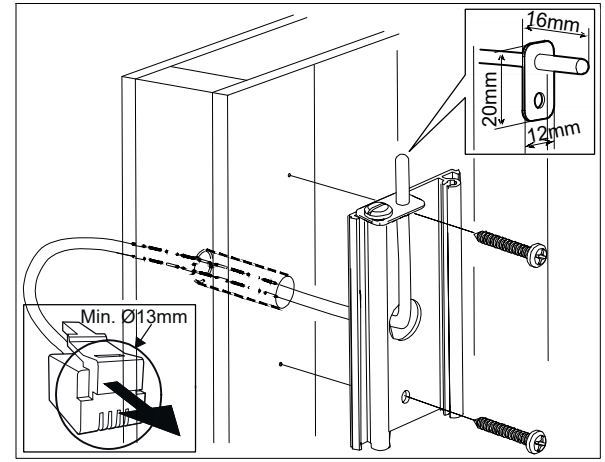



Fig 16: Ledningsdragning genom vägg.

ANSLUTNING/KOPPLINGSSCHEMA										
TAB	400-415 V 3N~ (C)		200-208 V 3~ (B)		230 V 3~ (B)		200-208 V~ (A) *		230-240 V~ (A) *	
Eff ekt kW	Strömstyr-ka amp	Lednings-area mm²	Strömstyr-ka amp	Lednings-area mm²	Strömstyr-ka amp	Lednings-area mm²	Strömstyr-ka amp	Lednings-area mm²	Strömstyr-ka amp	Lednings-area mm²
6,6	10	1,5	19	4	17	4	33	10	29	10
8	12	2,5	23	6	20	4	40	16	35	10
10,5	16	2,5	32	10	28	10	-	-	-	-

INSTALLATION OF SENSOR

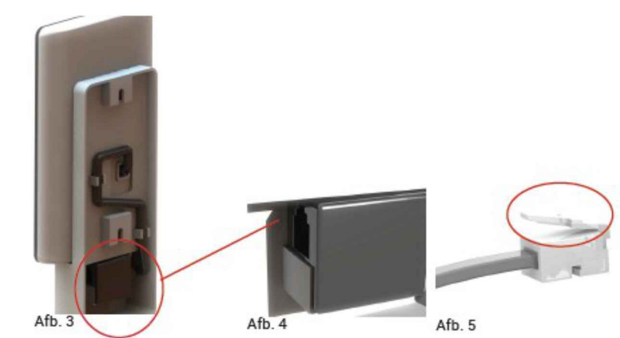

Installatie zonder beugel
Plak de dubbelzijdige tape op het bedieningspaneel. Voordat u het paneel aan de wand bevestigt, controleert u of alles werkt door het paneel aan te sluiten op het verwarmingselement. Verwijder de bescherming van de kleefstrook. Sluit de draad van het paneel aan, steek het contact door het gat in de wand en druk het paneel stevig tegen de wand.
Als het paneel zonder beugel wordt bevestigd maar de kabel langs de wand moet worden geleid, kunt u de volgende oplossing gebruiken (zie afbeelding 6). Dit geldt alleen voor installatie binnen de saunacabine. Het gat voor het contact moet minimaal 30 mm zijn

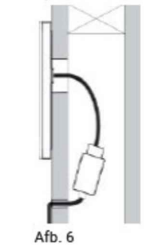

Afb. 6